



16' 8"
+/-

CUSTOM PRINT

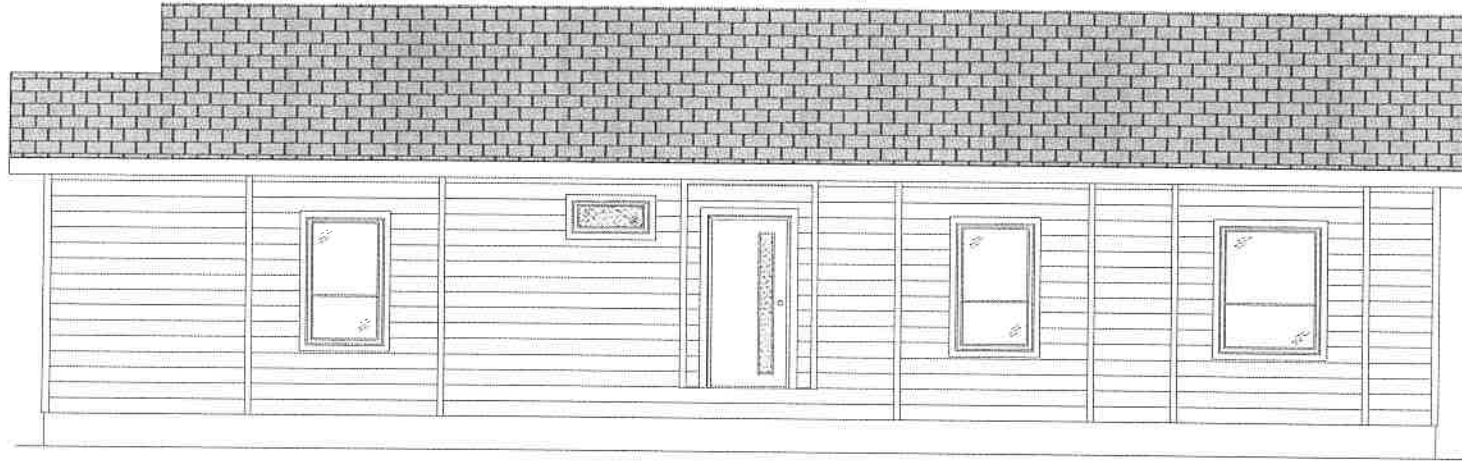


FRONT SIDE ELEVATION

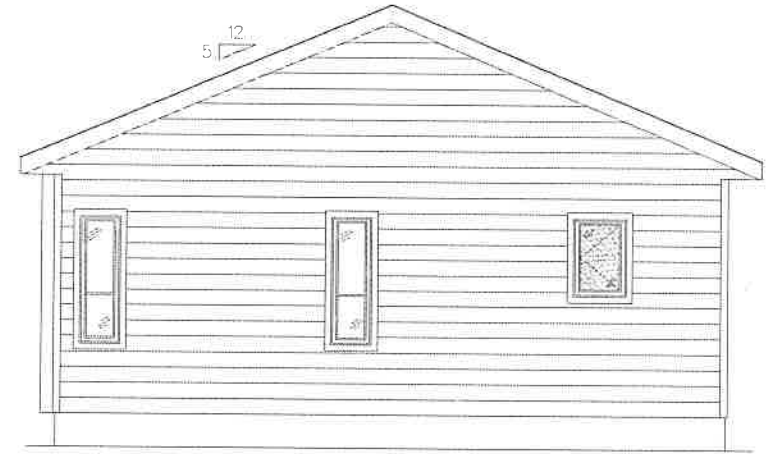

FRONT END ELEVATION



BACK END ELEVATION

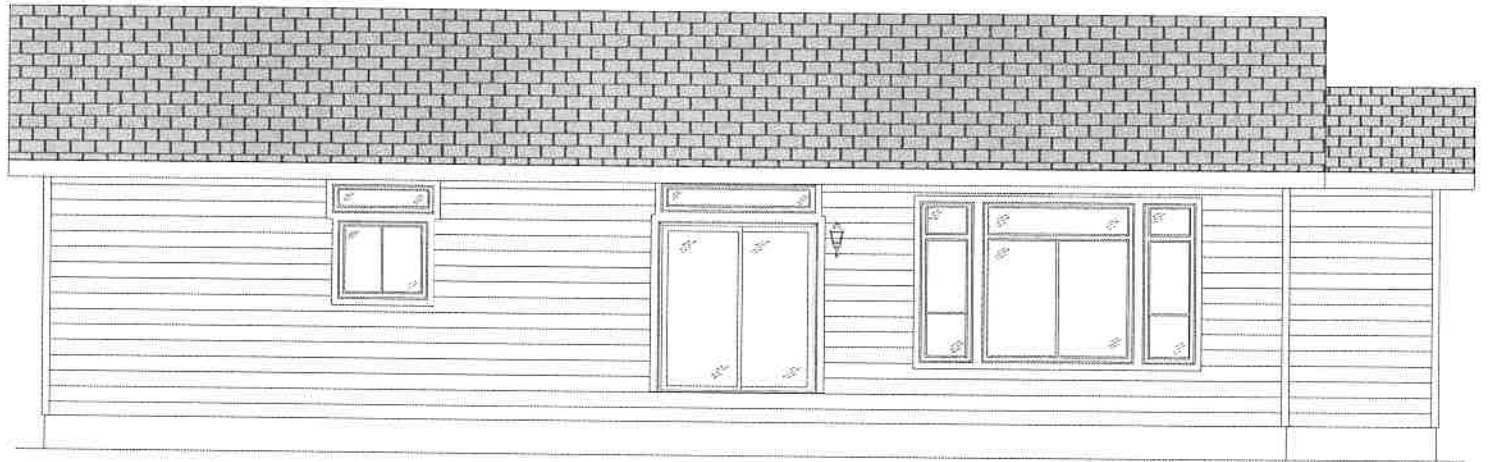

BACK SIDE ELEVATION

NOTES: CHAMPION HOMES ASSUMES NO RESPONSIBILITY FOR FIRE SEPARATION, SEISMIC OR DOOR/WINDOW PENETRATION REQUIREMENTS. CONSULT YOUR LOCAL BUILDING OFFICIAL OR ENGINEER OF RECORD TO CONFIRM.

Any renderings and depictions are conceptual only and are for the convenience of reference. They should not be relied upon as representations, express or implied, of the final detail of the Units. Moduline Industries expressly reserves the right to make modifications, revisions, and changes it deems desirable in its sole and absolute discretion. All depictions of appliances, counters, furniture, finishes, lighting, plumbing fixtures, soffits, floor coverings and other matters of detail are conceptual only and are not necessarily included in each Unit. Consult your Purchase Agreement and the Offering Documents for the items included with the Unit. Dimensions and square footage are approximate and may vary with actual construction.



CHAMPION HOMES - PENTICTON
P.O. BOX 190
1175 RAILWAY STREET
PENTICTON, B.C. V2A 6K3
(250) 493-0122

CUSTOMER: _____
DEALER: _____
DATE: _____

No.	DEALER CHANGE REQUEST

TITLE: CORNERSTONE	
DRAWN BY: KEA	DRAWING NO.: Q15788A-CUSTOM 27w-ELEVATION
DATE: 07/15/2026	
SCALE: NTS	